



Robb, Brenner, and Breig, Inc.  
225 S. Holmes - Suite 380  
Fort Collins, CO 80521

**RBB**

JOB NUMBER	9144
DRAWN	TMG, ULF
CHECKED	RDA
ISSUE	10/07/92
REVISIONS	


SHEET NAME  
NORTH POD  
PIPING PLAN

SHEET NUMBER  
15.4

**FLAG NOTES:**

- 1 SEE SITE PLAN FOR CONTINUATION.
- 2 REPLACE (E) LAV OR SINK WITH NEW SINK. CONNECT TO EXISTING 3", 1 1/2", 1", 3/4".
- 3 UNDERGARDEN RESTROOMS. MOUNT LAV-1 25 INCHES TO TOP OF BASIN RIM. MODIFY VALVE ACCESS PANEL AS REQUIRED TO FIT UNDER LAV.
- 4 WATER CLOSET, 1 1/2" CW, 2" V, 4" W.
- 5 LAV OR SINK, 1 1/2" CW, 1 1/2" HK, 1 1/2" V, 2" W.
- 6 2" FLOOR DRAIN 1 1/2" VENT, 2" W. DRAIN TO BE MOUNTED 1/4" TO 3/4" BELOW FINISHED FLOOR LEVEL. 30 FLOOR MAY BE SLOPED TO DRAIN. REF. ARCHITECTURAL.
- 7 1 1/2" V FROM LAV(S) COMBINE WITH 1 1/2" V FROM FD(S) TO 1 1/2". COMBINE 1 1/2" V WITH 1 1/2" WCO(S) TO BLDG. 2" V UP TO 3" VTR. OFFSET VTR MINIMUM 10" FROM AIR INTAKES OR EDGE OF BLDG.
- 8 SEE HANDICAPPED LAV ELEVATION SHEET 15.6.
- 9 REMOVE (E) EQUIPMENT, PATCH AND PAINT WALLS, CEILING, ETC. TO MATCH SURROUNDING REFERENCE ARCHITECTURAL.
- 10 REMOVE (E) PIPING TO POINT SHOWN. CAP OR PLUG AS REQUIRED. INACCESSIBLE PIPING MAY BE ABANDONED IN PLACE BEHIND WALLS, ETC. PATCH AND PAINT WALLS, CEILING, ETC. TO MATCH SURROUNDING REFERENCE ARCHITECTURAL.
- 11 NEW 1" HWS & HWR UNDER NEW CABINET, BEHIND KICK SPACE. CONNECT TO (E) 1 1/2" HWS AND HWR IN CHASE IN CORNER.
- 12 REPLACE (E) SANITARY OR STORM SEWER WITH CAST IRON UNDER NEW ADDITION. VERIFY EXACT SIZE AND LOCATION IN FIELD.
- 13 (E) WATER SPRINKLER MAN-HOLE AND RELATED PIPING TO BE REMOVED.
- 14 SEE EVAP. COOLER PIPING SCHEMATIC SHEET 15.6.
- 15 CONNECT NEW SEWER PIPING TO (E) UNDER FLOOR. SAW OUT FLOOR AS REQUIRED. VERIFY LOCATION OF (E) SEWER PRIOR TO MAKING ANY CUTS. COMBINE VENTS AND OFFSET TO A 3" VTR. MINIMUM 10 FEET FROM RTU AIR INTAKE.
- 16 CONFIRM FINNED TUBE RADIATION WILL FIT BESIDE (E) GAS PIPING OR UNDER PIPE. IF NEEDED, MOVE LOCATION OF FTR SOUTH TO AVOID CONFLICT. OFFSET PIPING AS REQUIRED.
- 17 WALL HYDRANT, 3/4" CW, MOUNT 1" AFF. ISOLATION VALVE ABOVE CEILING OR BEHIND CABINET.
- 18 DISCONNECT (E) KITCHEN HW & HWC FROM MAINS. CONNECT NEW 1/2" DEG. F. HW AND HWC TO (E) KITCHEN HW & HWC. CONNECT (E) MAIN HWS INTO (E) TRM MAIN.
- 19 COORDINATE LOCATION OF PIPES WITH DUCTWORK IN CHASE.


**PARTIAL NORTH POD PIPING PLAN**  
1/8" = 1'-0"

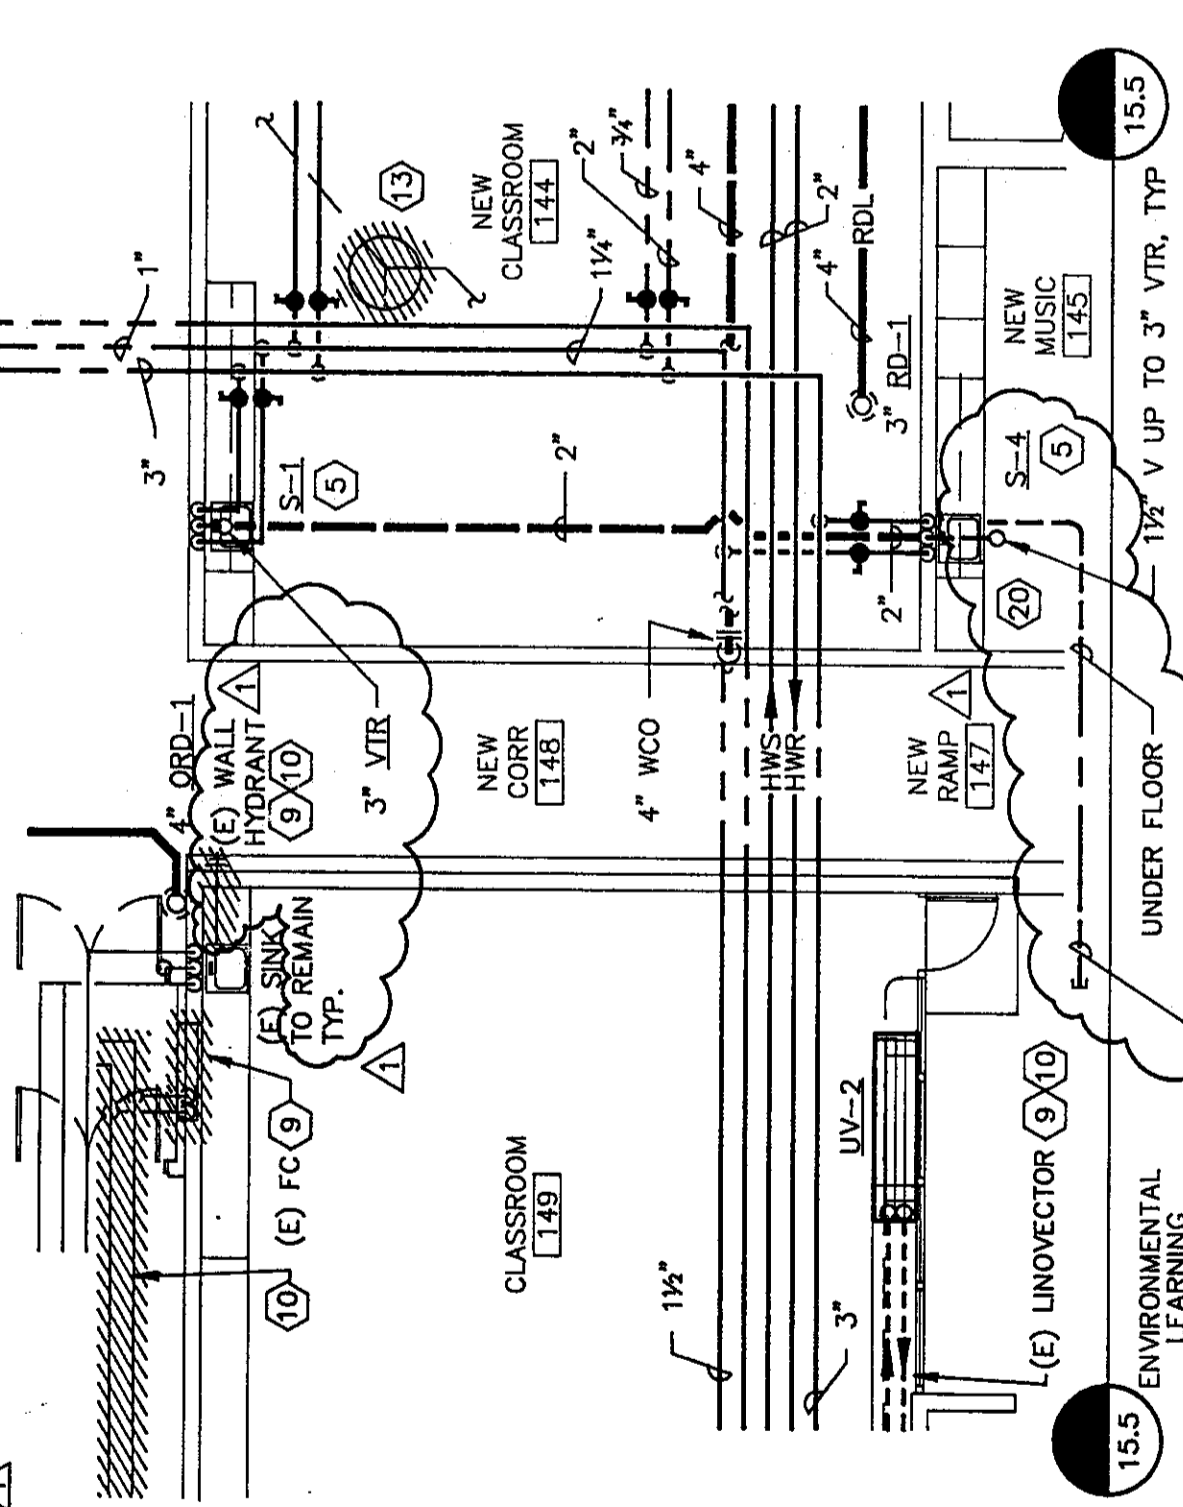

SK-1

CLIENT: RBB, BRENNER, AND BREIG  
PROJECT: CACHE LA Poudre ELEMENTARY ADDITION & REMODEL  
DATE: 10/22/92  
DRAWN BY: TMG, ULF  
CHECKED BY: RDA  
COMPUTER FILE NAME: 9144SK-1.DWG

**PARTIAL NORTH POD PIPING PLAN**  
1/8" = 1'-0"

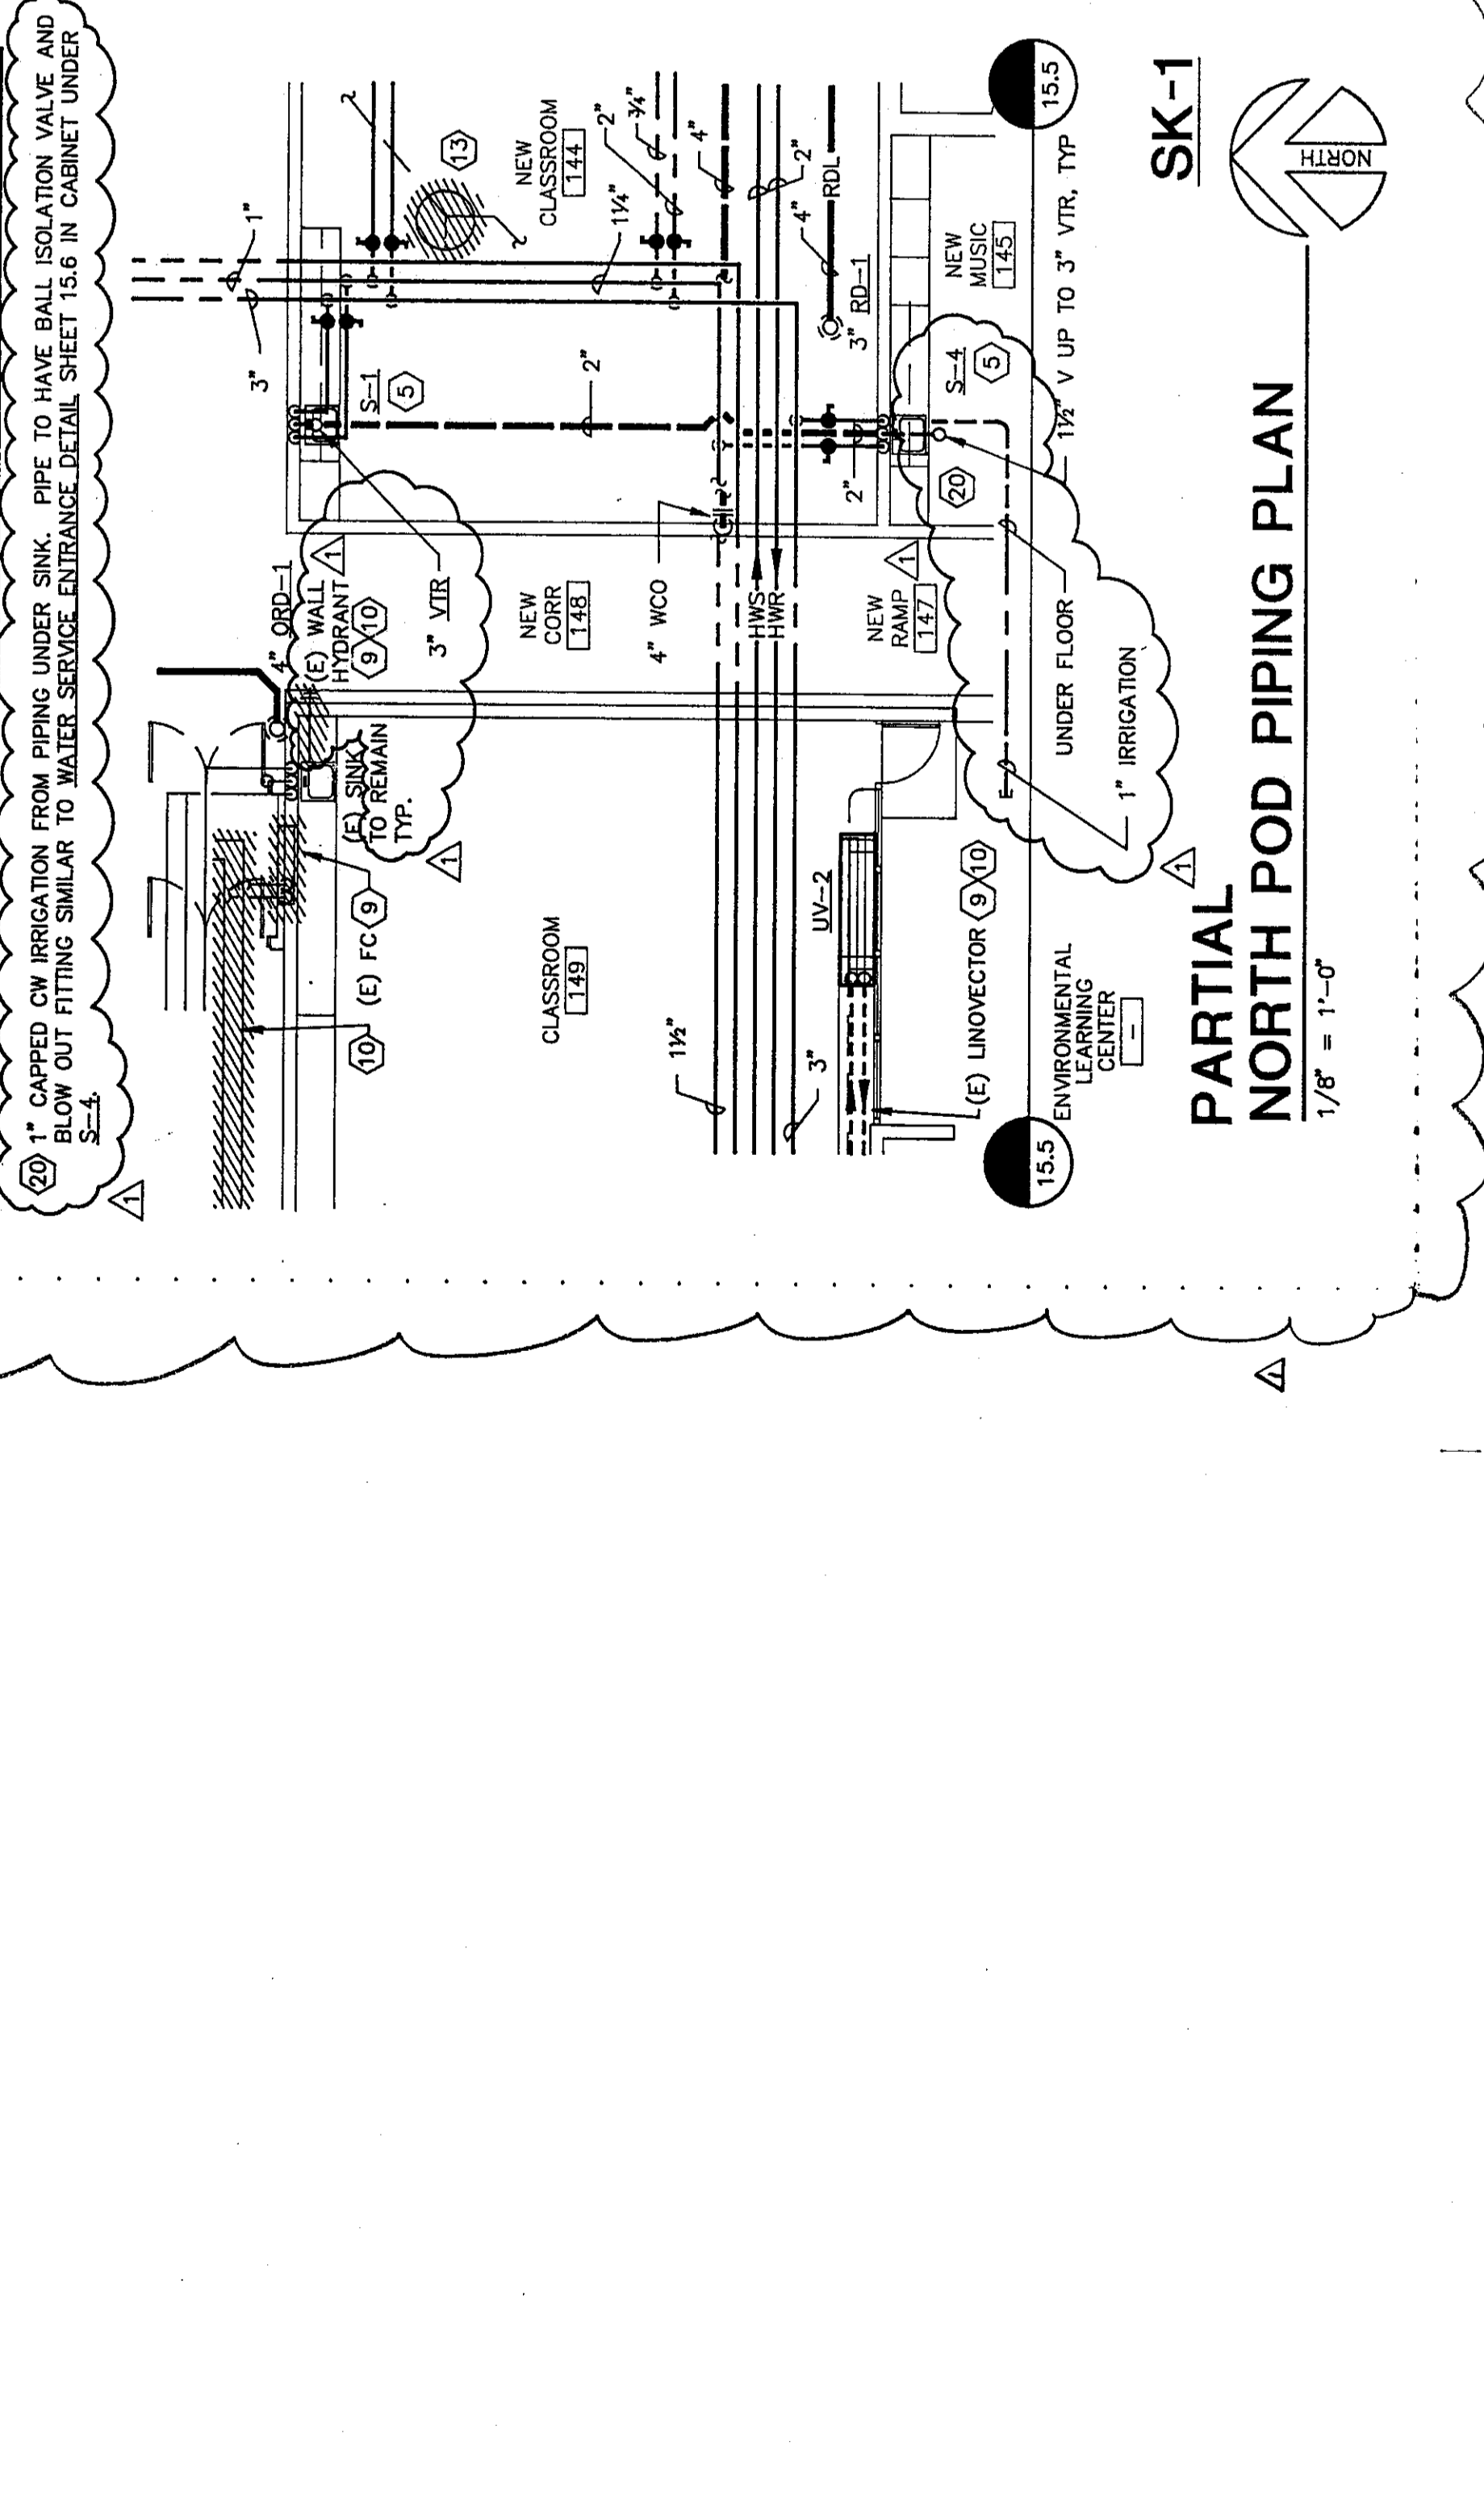

CITY OF GREELEY - BELLEVUE TREATMENT PLANT  
WATER PIPE 27"

THIS SECOND DRAWING HAS BEEN REVISED UPON INFORMATION FURNISHED BY DESIGN PROFESSIONAL CANNOT BE HELD RESPONSIBLE FOR THE WHICH MAY HAVE BEEN OBTAIN INDEPENDENTLY BEFORE APPLYING IT FOR ANY PURPOSE.