



ALL WORK DELETED  
BY OWNER

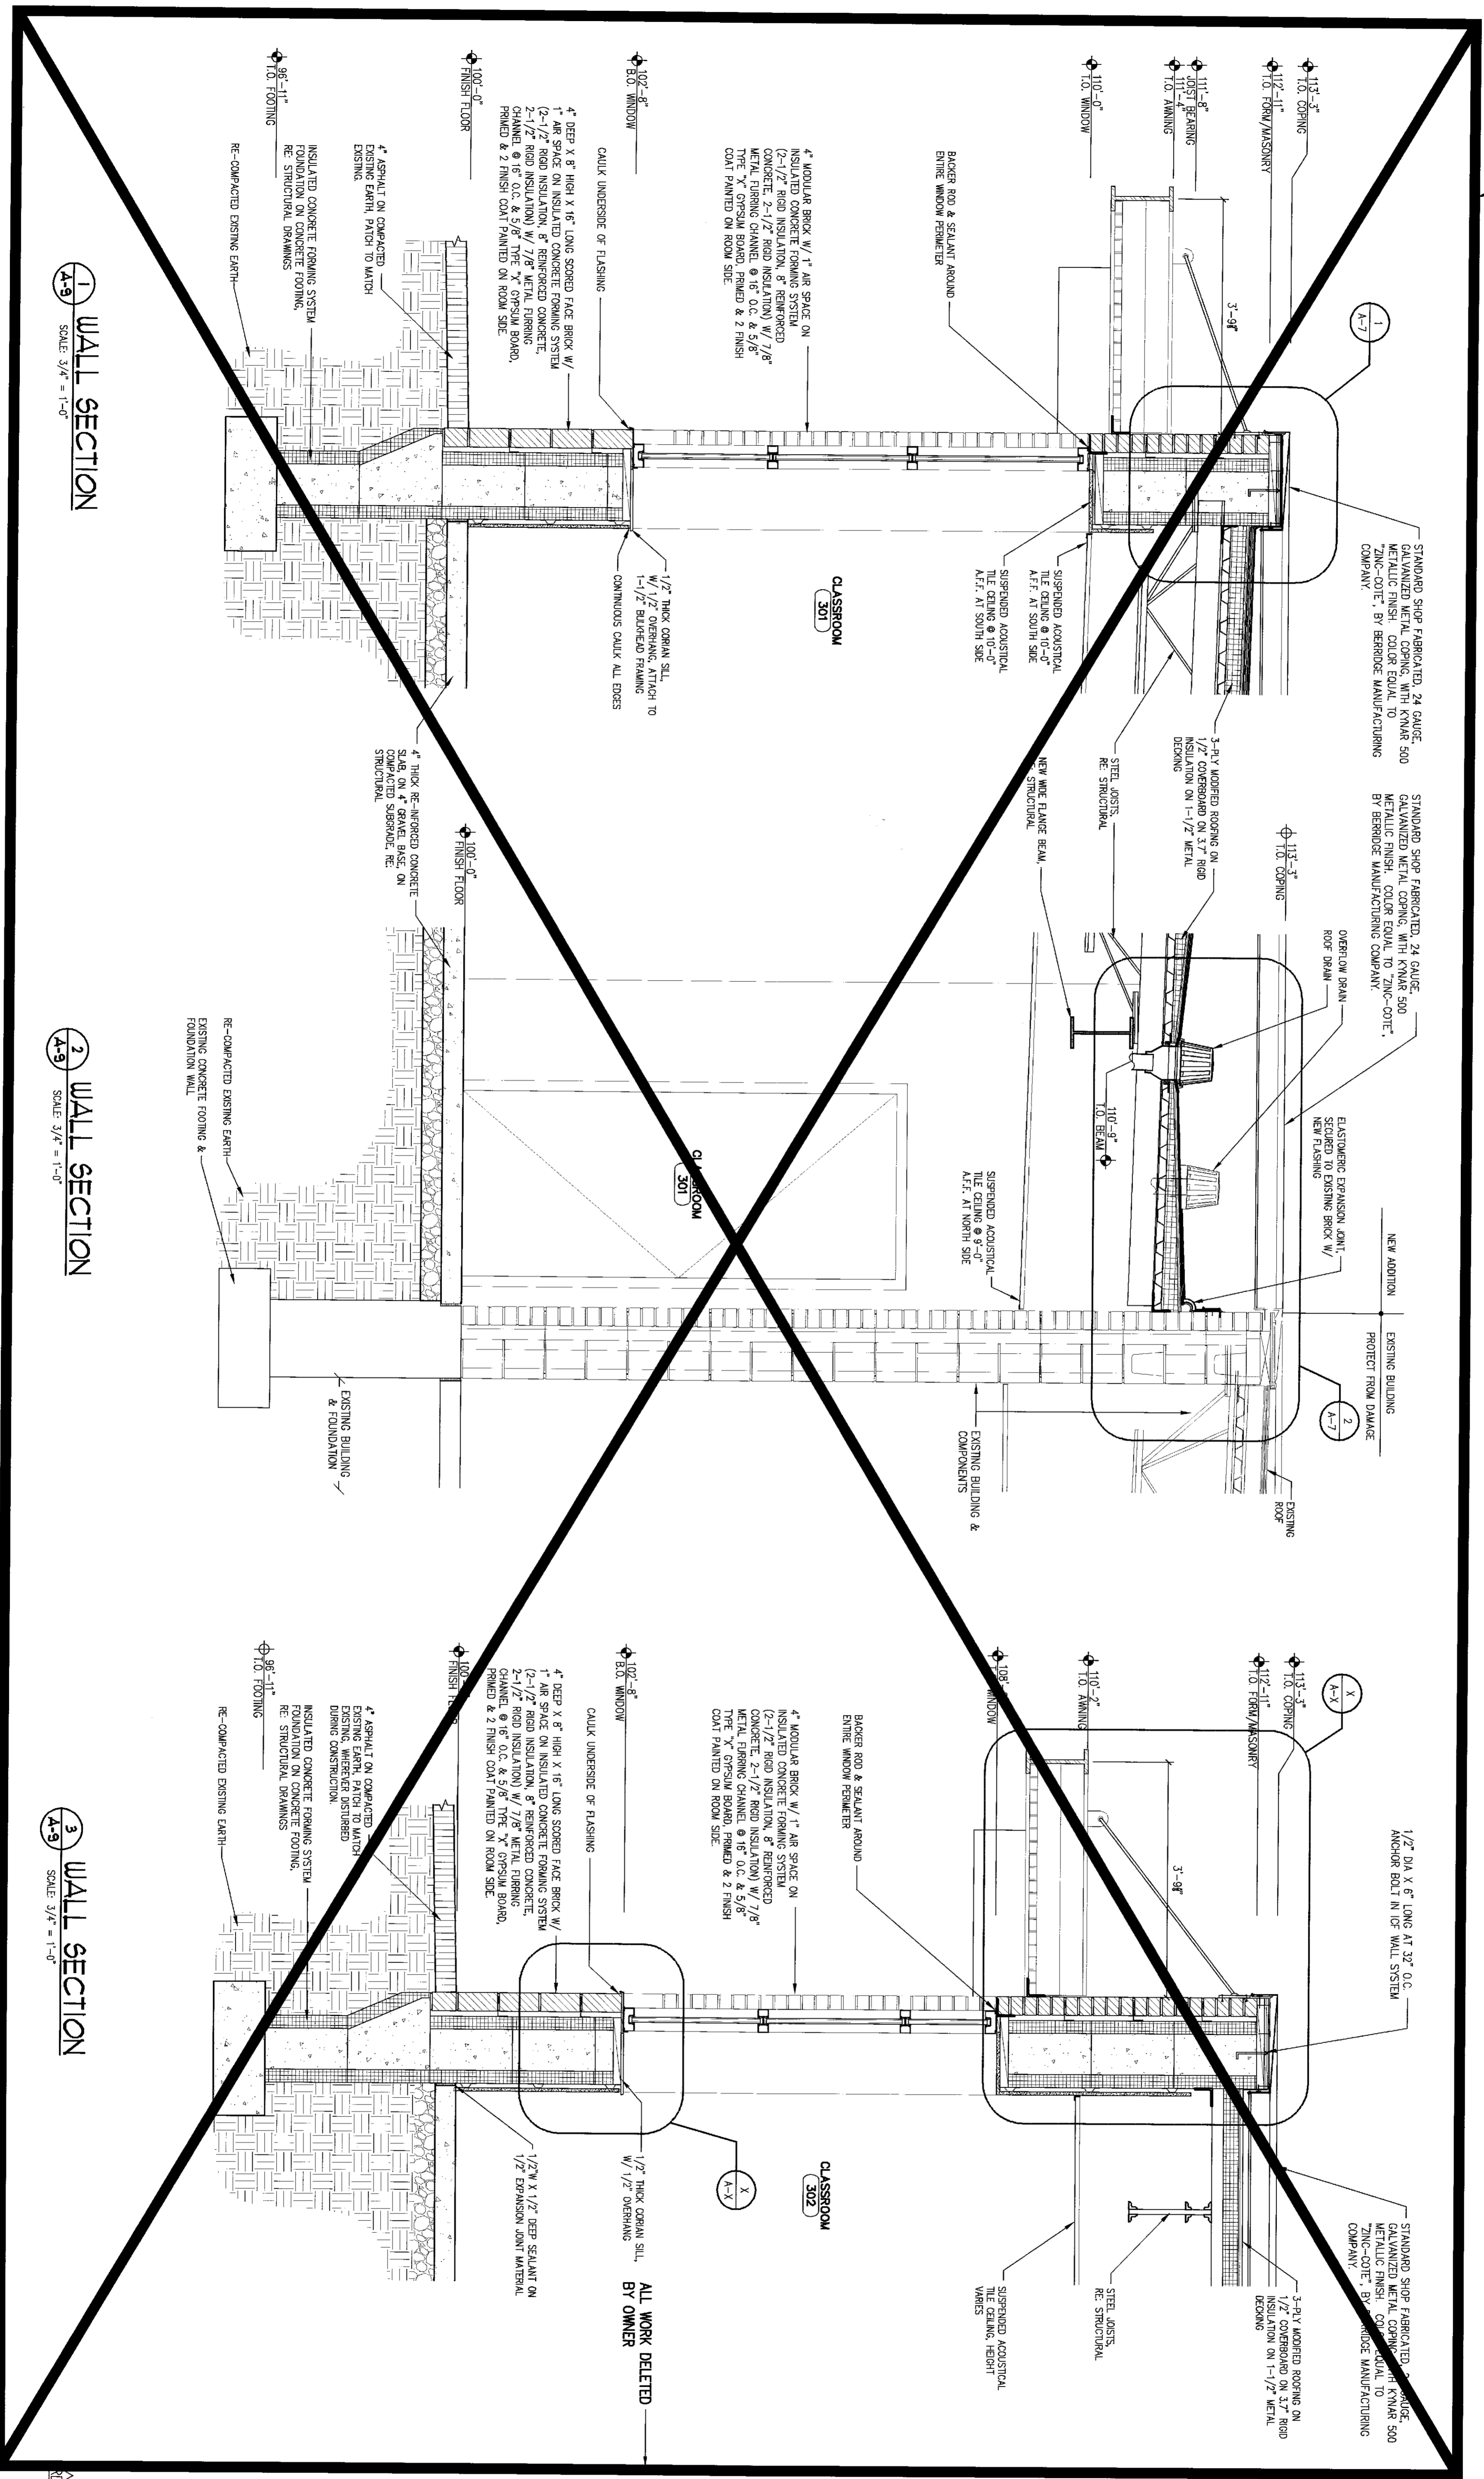

1 WALL SECTION  
SCALE 3/4" = 1'-0"

2 WALL SECTION  
SCALE 3/4" = 1'-0"

3 WALL SECTION  
SCALE 3/4" = 1'-0"

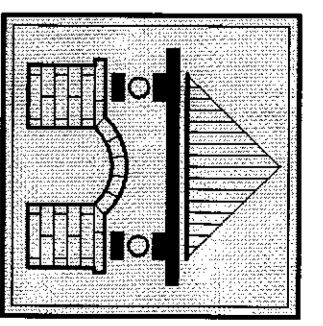

MELLIN & ASSOCIATES  
ARCHITECTS, P.C.  
5570 East Yale Avenue  
Denver, CO 80222  
Phone: 303-981-2846  
Fax: 303-981-1899

CONSULTANTS:

**STRUCTURAL ENGINEER**  
Sunquest Design Group  
12139 West Bayview Avenue  
Suite 102  
Lakewood, CO 80122  
303-904-4859  
303-904-4899  
Contact: Joe Sunquest P.E.  
303-904-4899

**MECHANICAL ENGINEER**  
Givens & Associates, Inc.  
725 South Xenon Ct.  
Suite 201  
Lakewood, CO 80128  
303-755-8700  
303-755-8702  
Contact: Jeff A. Givens P.E.

**ELECTRICAL ENGINEER**  
Aber Engineering Inc.  
10489 Bradford  
Colorado Springs, CO 80912  
303-898-5860  
303-987-2804 Fax  
Contact: Clarence Bernall

PROJECT TITLE:

Classroom Addition &  
Cafeteria Renovation  
for  
Caché La Poudre  
Elementary School  
Poudre School District

ISSUED

REVISIONS	DATE
D.D.'s	04-06-06
95% C.D.'s	05-01-06
100% C.D.'s	05-08-06
RECORD DOCUMENTS	06-08-07

TITLE  
WALL  
SECTIONS

A-9  
SHEET A-9 OF 24